


LEGEND	
	SMOKE DETECTOR
	HEAT DETECTOR
	EMERGENCY LIGHT
	EXIT LIGHT

LEGEND	
	SPRINKLER
	5.0 kg. CO2 FIRE EXTINGUISHER
	4.0 kg. DRY POWDER FIRE EXTINGUISHER
	BRAKE GLASS
	SUNDER

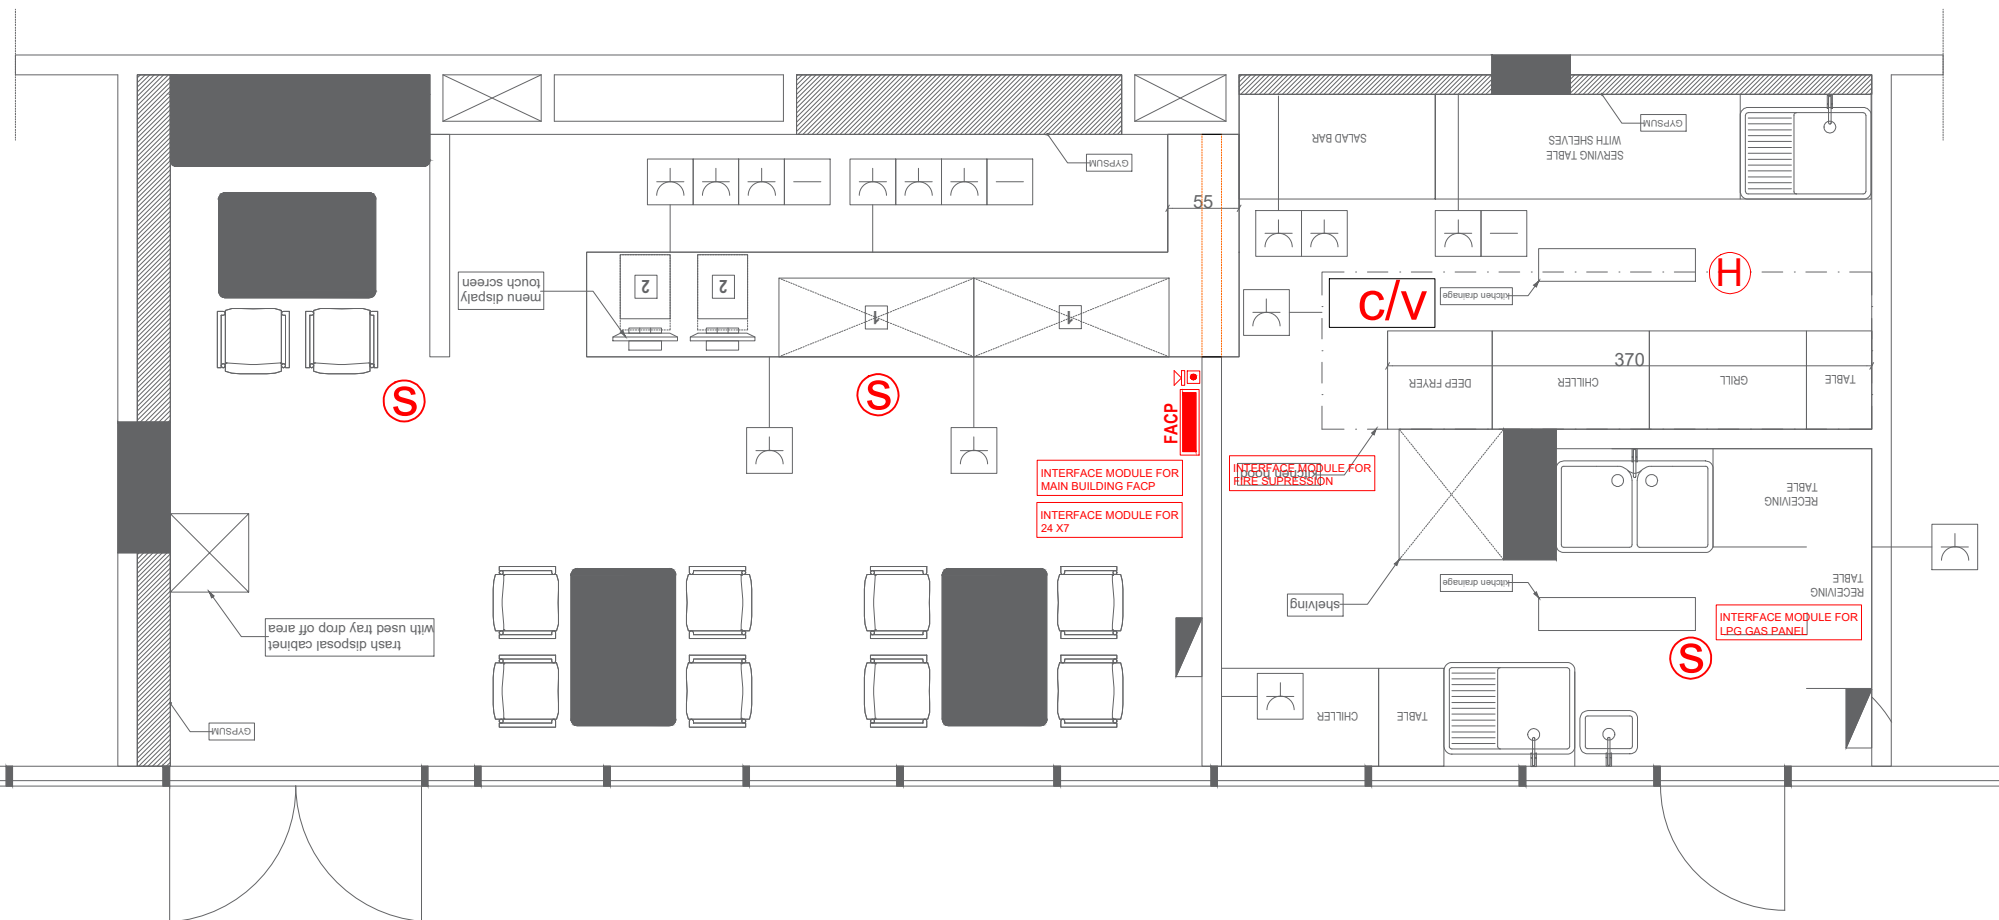

CLIENT :			
BIG MOUTH CAFE			
PROJECT TITLE: BIG MOUTH cafe			
LOCATION : Off-campus student housing complex, Academic City, Dubai, UAE			
SHOP NUMBERS : G, GF-RE-005 and G, GF-RE-006			
FIRE CONTRACTOR			
BLOCK:	LOT:	LOCATION:	
		8120287	
SCALE	DLT. BY	CKD. BY	
AS SHOWN	SRI	VEN	
DATE	PROJ. NO:		
2-2-2020			
DRAWING TITLE:			
FIRE ALARM SYSTEM LAYOUT PLAN			
DWG. NO. :			
FIRE-101			